


**NOTES**

1. 14" ROOF PITCH
2. 2X10 RAFTER @ 24" O.C.
3. CONCRETE FLAT TILE
4. (19) LG LG315N1C-G4 PV MODULES
5. (19) SOLAREGE P320 DC OPTIMIZERS
6. QUICKMOUNT TILE HOOK
7. IRONRIDGE XR10 RAIL
8. A MIN OF 3'-0" CLEARANCE BETWEEN PANELS ON CONNECTING ROOFS
9. A MIN OF 3'-0" CLEARANCE BETWEEN TOP OF PANELS AND THE RIDGE OF THE ROOF

**KEY/ COMPONENTS**

	SOLAREGE P320 DC OPTIMIZERS
	LG315N1C-G4- PV MODULE E
	NEMA 3R JBOX
	3/4" EMT CONDUIT

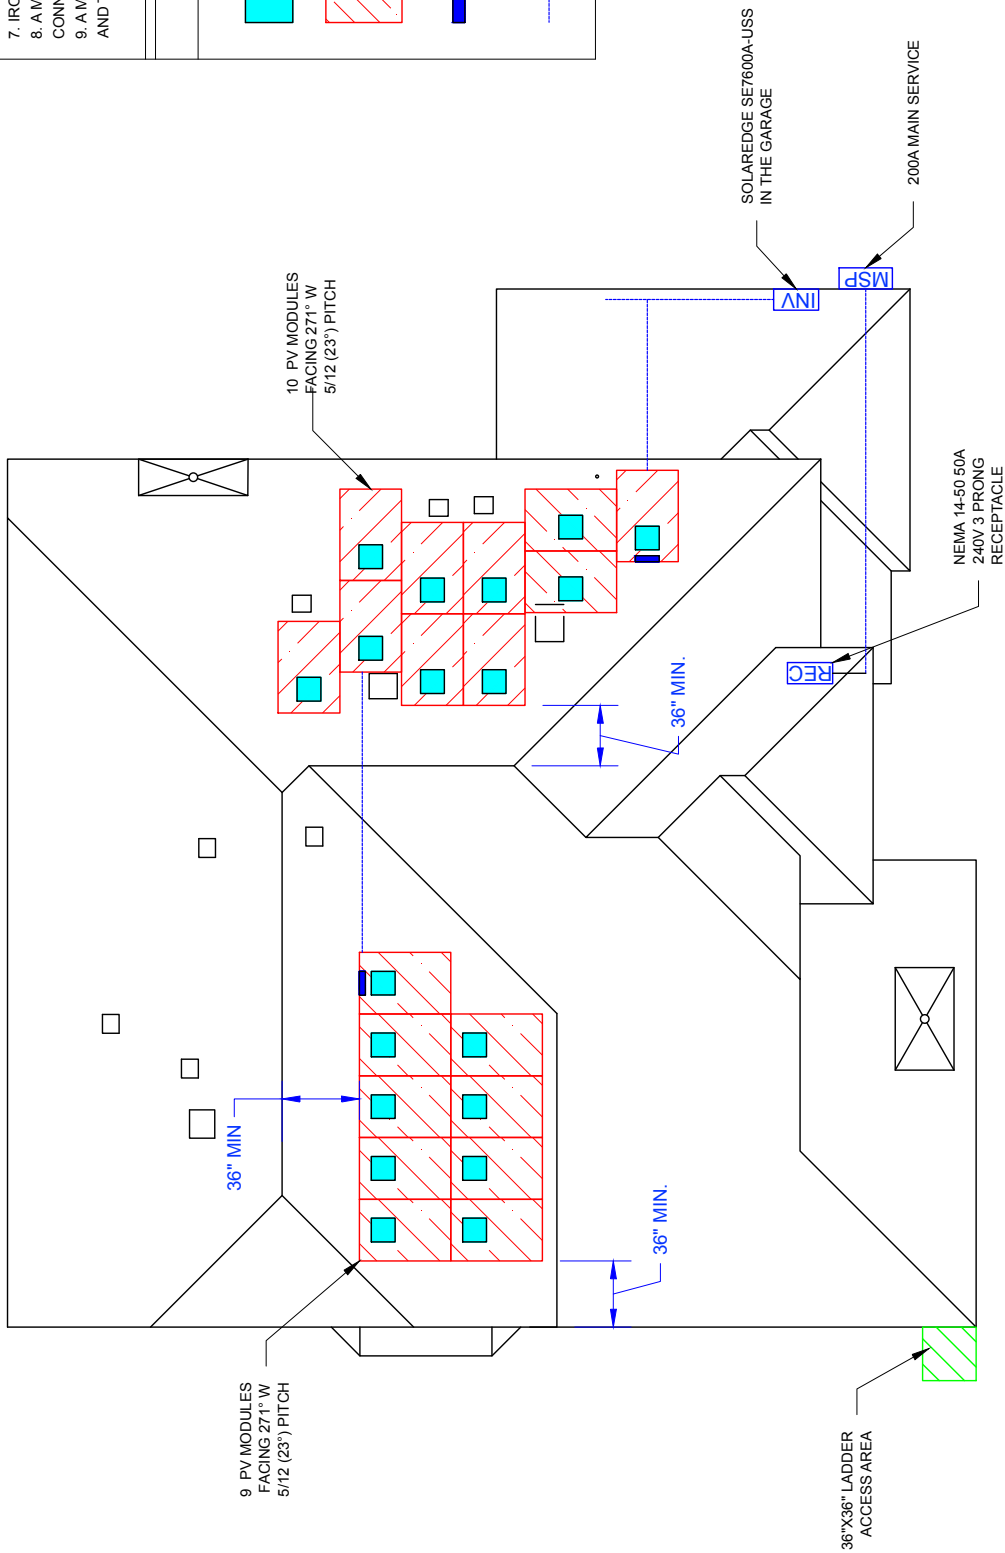

**ROOF PLAN LAYOUT**  
SCALE: 3/64" = 1'-0"

